



ALLOWANCES FOR CABLE

LOCATION	LENGTH (ft)
A to B	Min. 16ft (5m) cable or longer as required to reach Hub mounting location
B to C - Inside Tank Riser	Allow min. 3ft (1m) at each cable end + distance between sensors.
D,E,F,G - Inspection Port / Valve Box	Allow min. 2ft (0.6m) at each cable end + distance between sensors

Note:
Cables come in lengths of 50ft (15m) and 16ft (5m). They may be connected to achieve the required total length.

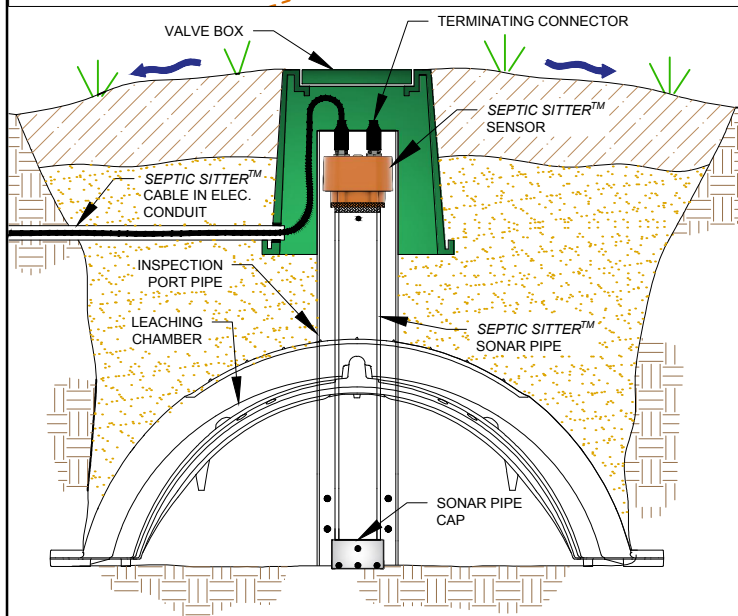

CROSS SECTION SHOWING SEPTIC SITTER™ SENSOR WITH TERMINATING CONNECTOR

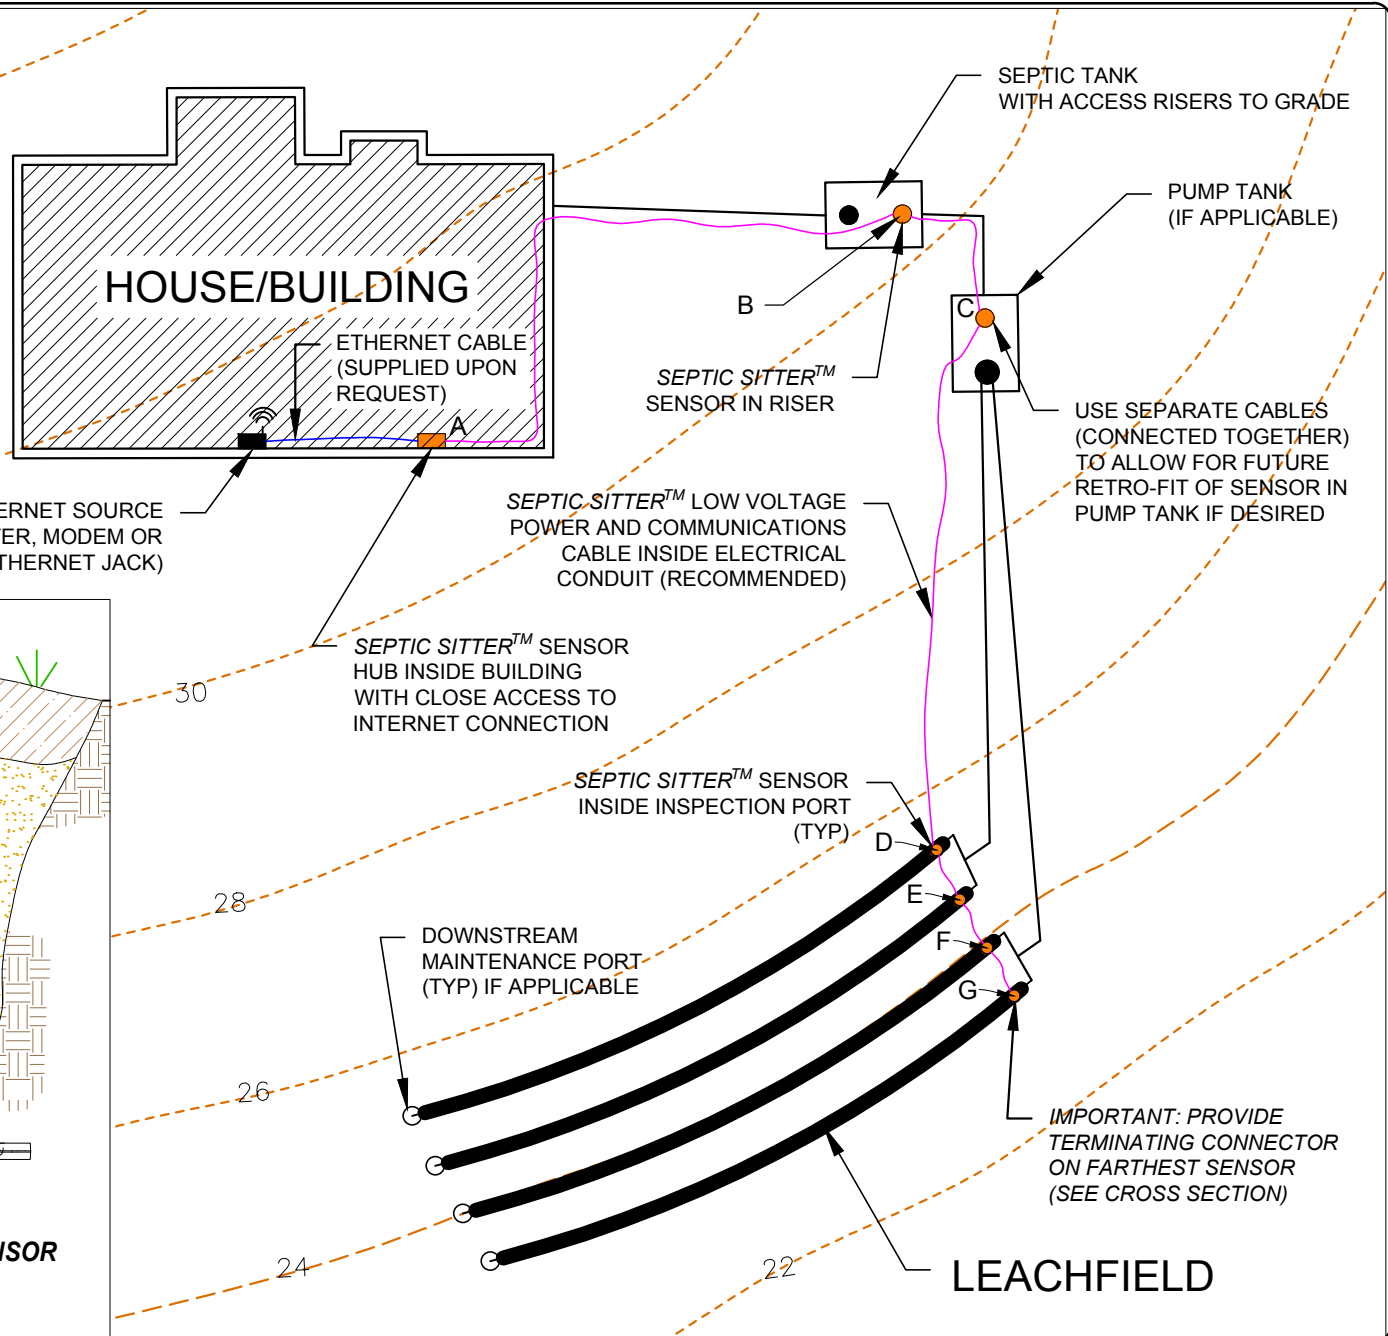

DYNAMIC
MONITORS.COM

1-888-747-7645 Toll Free

PROJECT: SEPTIC SITTER™				JOB NO: NA	
TITLE: SEPTIC SITTER™ EXAMPLE SITE PLAN LAYOUT					
SCALE: NTS	FILE: D-301	CHK: KAG	DRAWN BY: SCR	DATE: Feb 19, 2017	